



专业	姓名	日期	专业	姓名	日期
建筑			暖通		
结构			电气		
给排水			装饰		

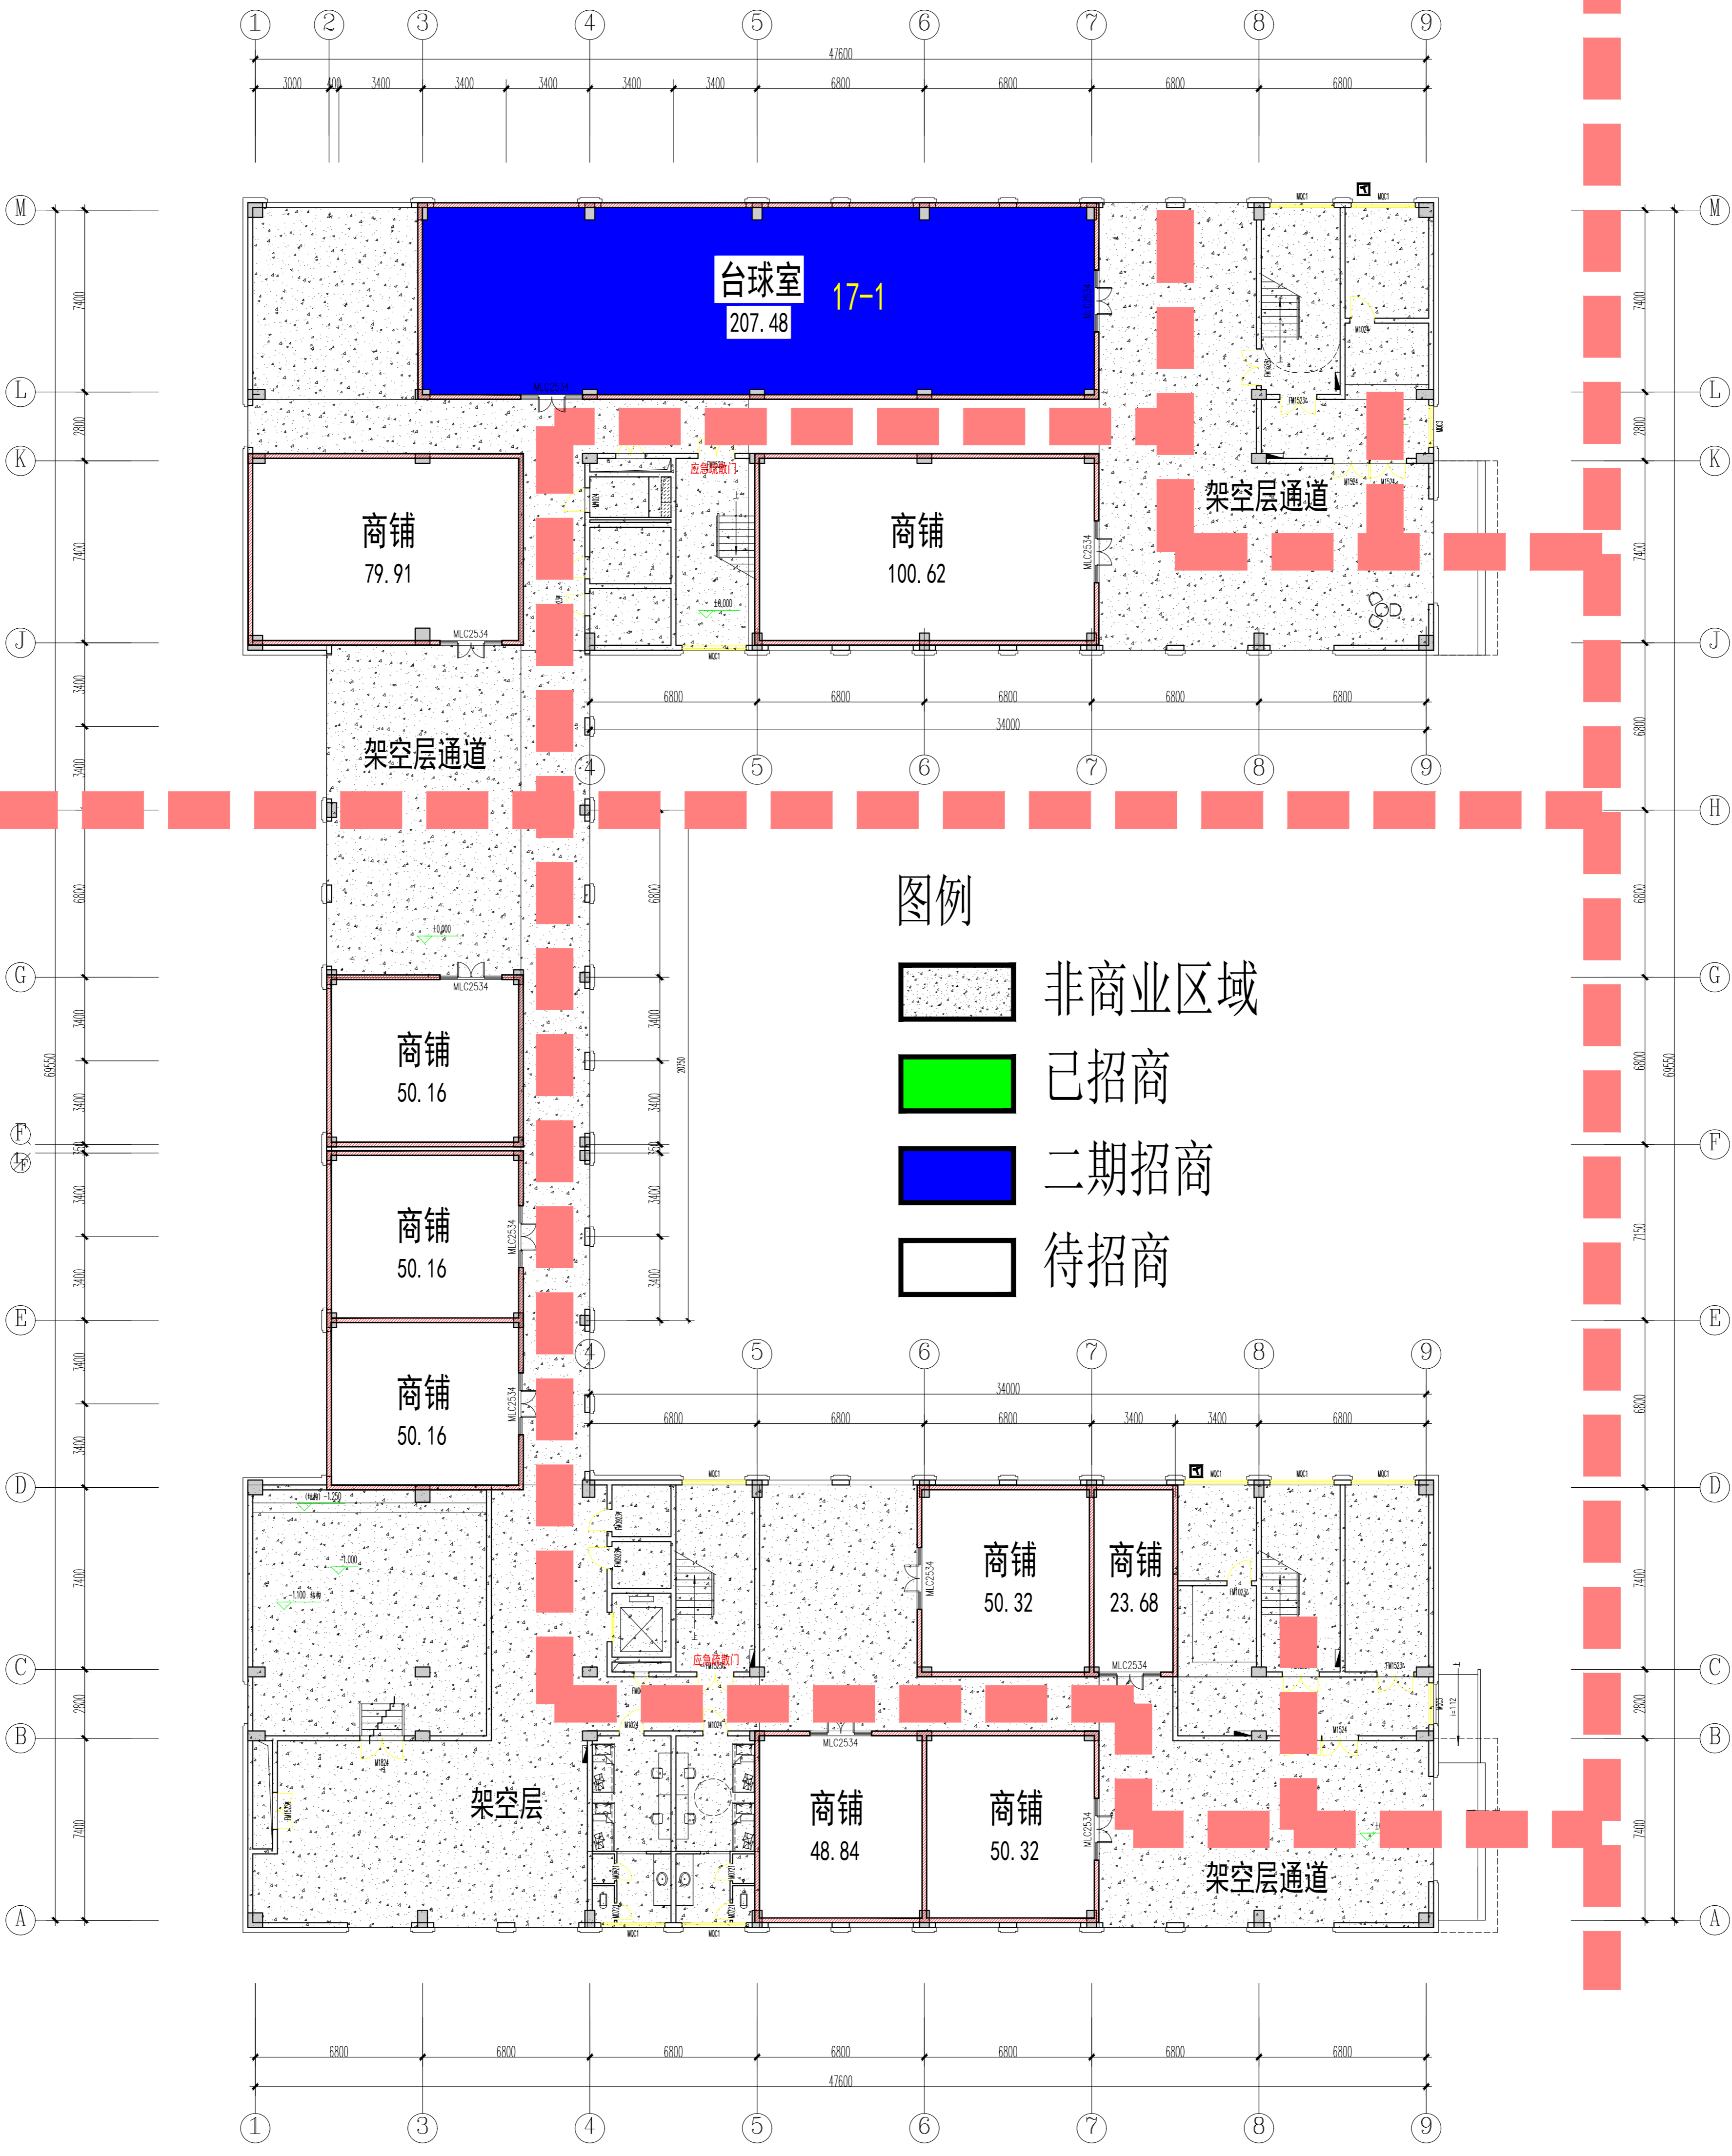

一层平面图 (改造) 1:150

<p>湖北佳境建筑设计有限公司 HUBEI JIANG ARCHITECTURAL DESIGN CO., LTD. 设计注册编号: 442008315 No.442008315 (Class 1 of Architecture Design (No.))</p>		<p>湖北佳境建筑设计有限公司 HUBEI JIANG ARCHITECTURAL DESIGN CO., LTD. 设计注册编号: 442008315 No.442008315 (Class 1 of Architecture Design (No.))</p>	
<p>THE DRAWING IS AN INSTRUMENT OF SERVICE IS AND REMAINS THE EXCLUSIVE PROPERTY OF SERVICE IS AND IS NOT TO BE REPRODUCED, COPIED, REPRODUCED, OR TRANSMITTED IN ANY FORM OR BY ANY MEANS, WITHOUT THE WRITTEN PERMISSION. SERVICE IS AND ITS DESIGNERS, ARCHITECTS, ENGINEERS, AND OTHER PROFESSIONALS SHALL NOT BE HELD RESPONSIBLE FOR ANY DAMAGE, LOSS, OR INJURY THAT MAY BE CAUSED BY THE USE OF THIS DRAWING. THIS DRAWING IS NOT TO BE USED FOR ANY OTHER PROJECT OR FOR ANY OTHER PURPOSE WITHOUT THE WRITTEN PERMISSION FROM OUR COMPANY.</p>			
<p>注册建筑师姓名: 张建华 注册结构师姓名: 胡朝川 注册暖通师姓名: 张建华 注册电气师姓名: 胡朝川 注册给排水师姓名: 胡朝川 注册装饰师姓名: 胡朝川 注册其他: 胡朝川</p>			
<p>项目负责人: 张建华 项目负责人: 胡朝川 专业负责人: 胡朝川 审定人: 张建华 审核人: 胡朝川 设计人: 胡朝川 校对人: 胡朝川 制图人: 胡朝川</p>			
<p>建设单位: 黄石市城发物业管理有限公司 项目名称: 湖北工程学院新校区 (生活区) 改造项目: 17#楼 一层平面图 (改造)</p>			
<p>设计号: 2022-01-07 专业: 建筑 日期: 2022.07 图号: 建筑-06 版本号: A 页码: 1/1</p>			
<p>注册建筑师姓名: 张建华</p>			

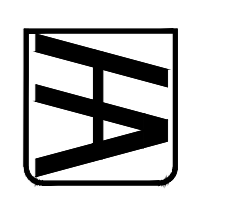

AI1400-841X34